



200kW PV plant,
Inverter Capacity: 50kW
Number of Inverter: 4
PV Module Capacity: 595W
Number of PV Module: 340
Total DC Power: 202,300 W
Max Ac Power: 200kW

10 Tables 9 panels
25 Tables 10 panels
340 panels

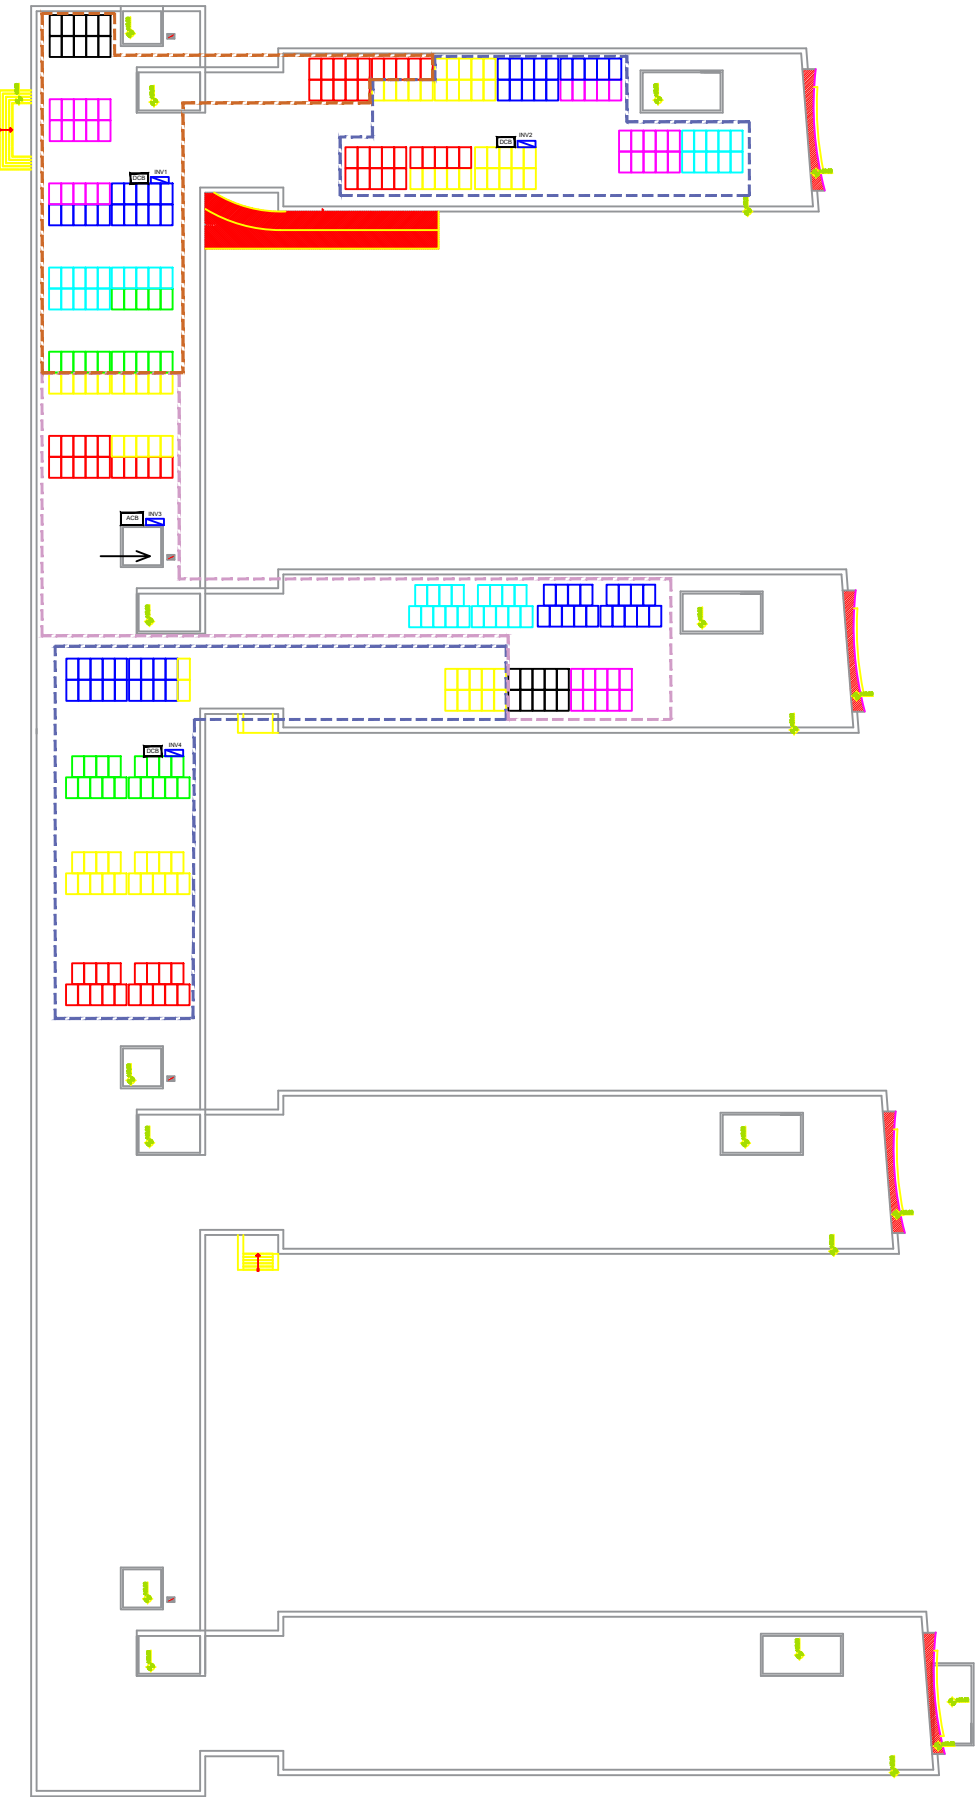

Rev	Date	Description	Achieve	Check
12.08.2025		IFC		
Client :		Tamin Energy Mana		
Consultant :		Pishtaz Energy		
Project :		Vice-Presidency for200kW Power Plant		
Design :		Abbasi		
Drawn :		Abbasi		
Check :		Shahrani		
Approve :		Ahmadi		
Description :		Plot Plan		
Dwg. Number :		MEPELOPLN001_100.011.0		
Total Sheet :		01		

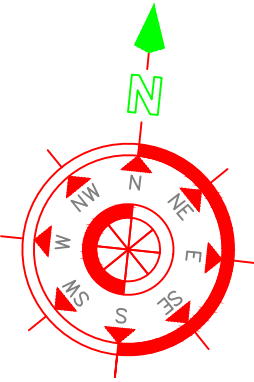